

**MONTENARO
JACKSONVILLE
HOUSE**
NEW CONSTRUCTION

CLIENT

Montenaro USA, LLC
2016 Seva Modern Court
Atlantic Beach, FL 32233

ARCHITECT

VA Concepts, LLC
506 Third Street South
Jacksonville Beach, FL 32250
FL NO. A43001354


STRUCTURAL

Driscoll Engineering, Inc.
4509 NW 23rd Avenue
Gainesville, FL 32606
FL NO. 43972
Certificate of Authorization No. 8890

MECHANICAL & PLUMBING

ELECTRICAL

CONSULTANT

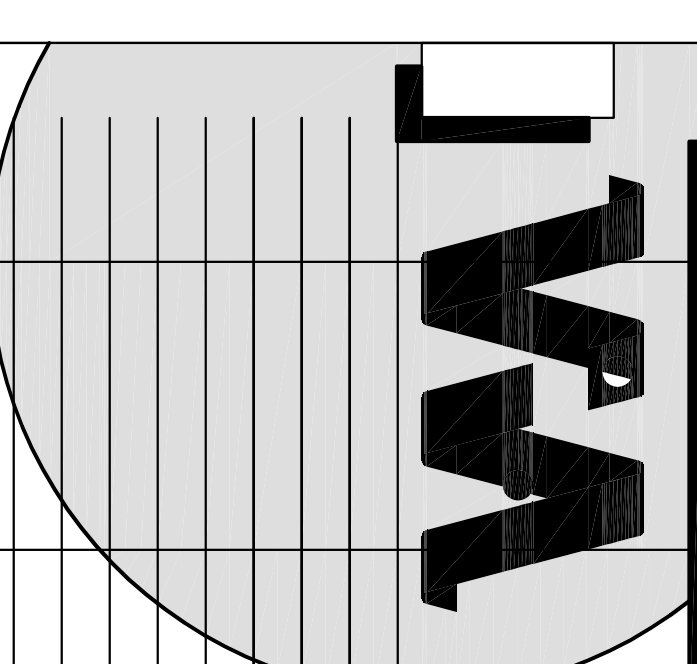


NO.	REVISION/ISSUE	DATE

**PROPOSED
GROUND FLOOR
PLAN -
14' x 25'
MODULE**

PERMIT
DOCUMENTS

COORDINING PROJ. NO.	PROJ. NO.	REV. NO.	DATE	AS SHOWN SCALE	DATE

A-200

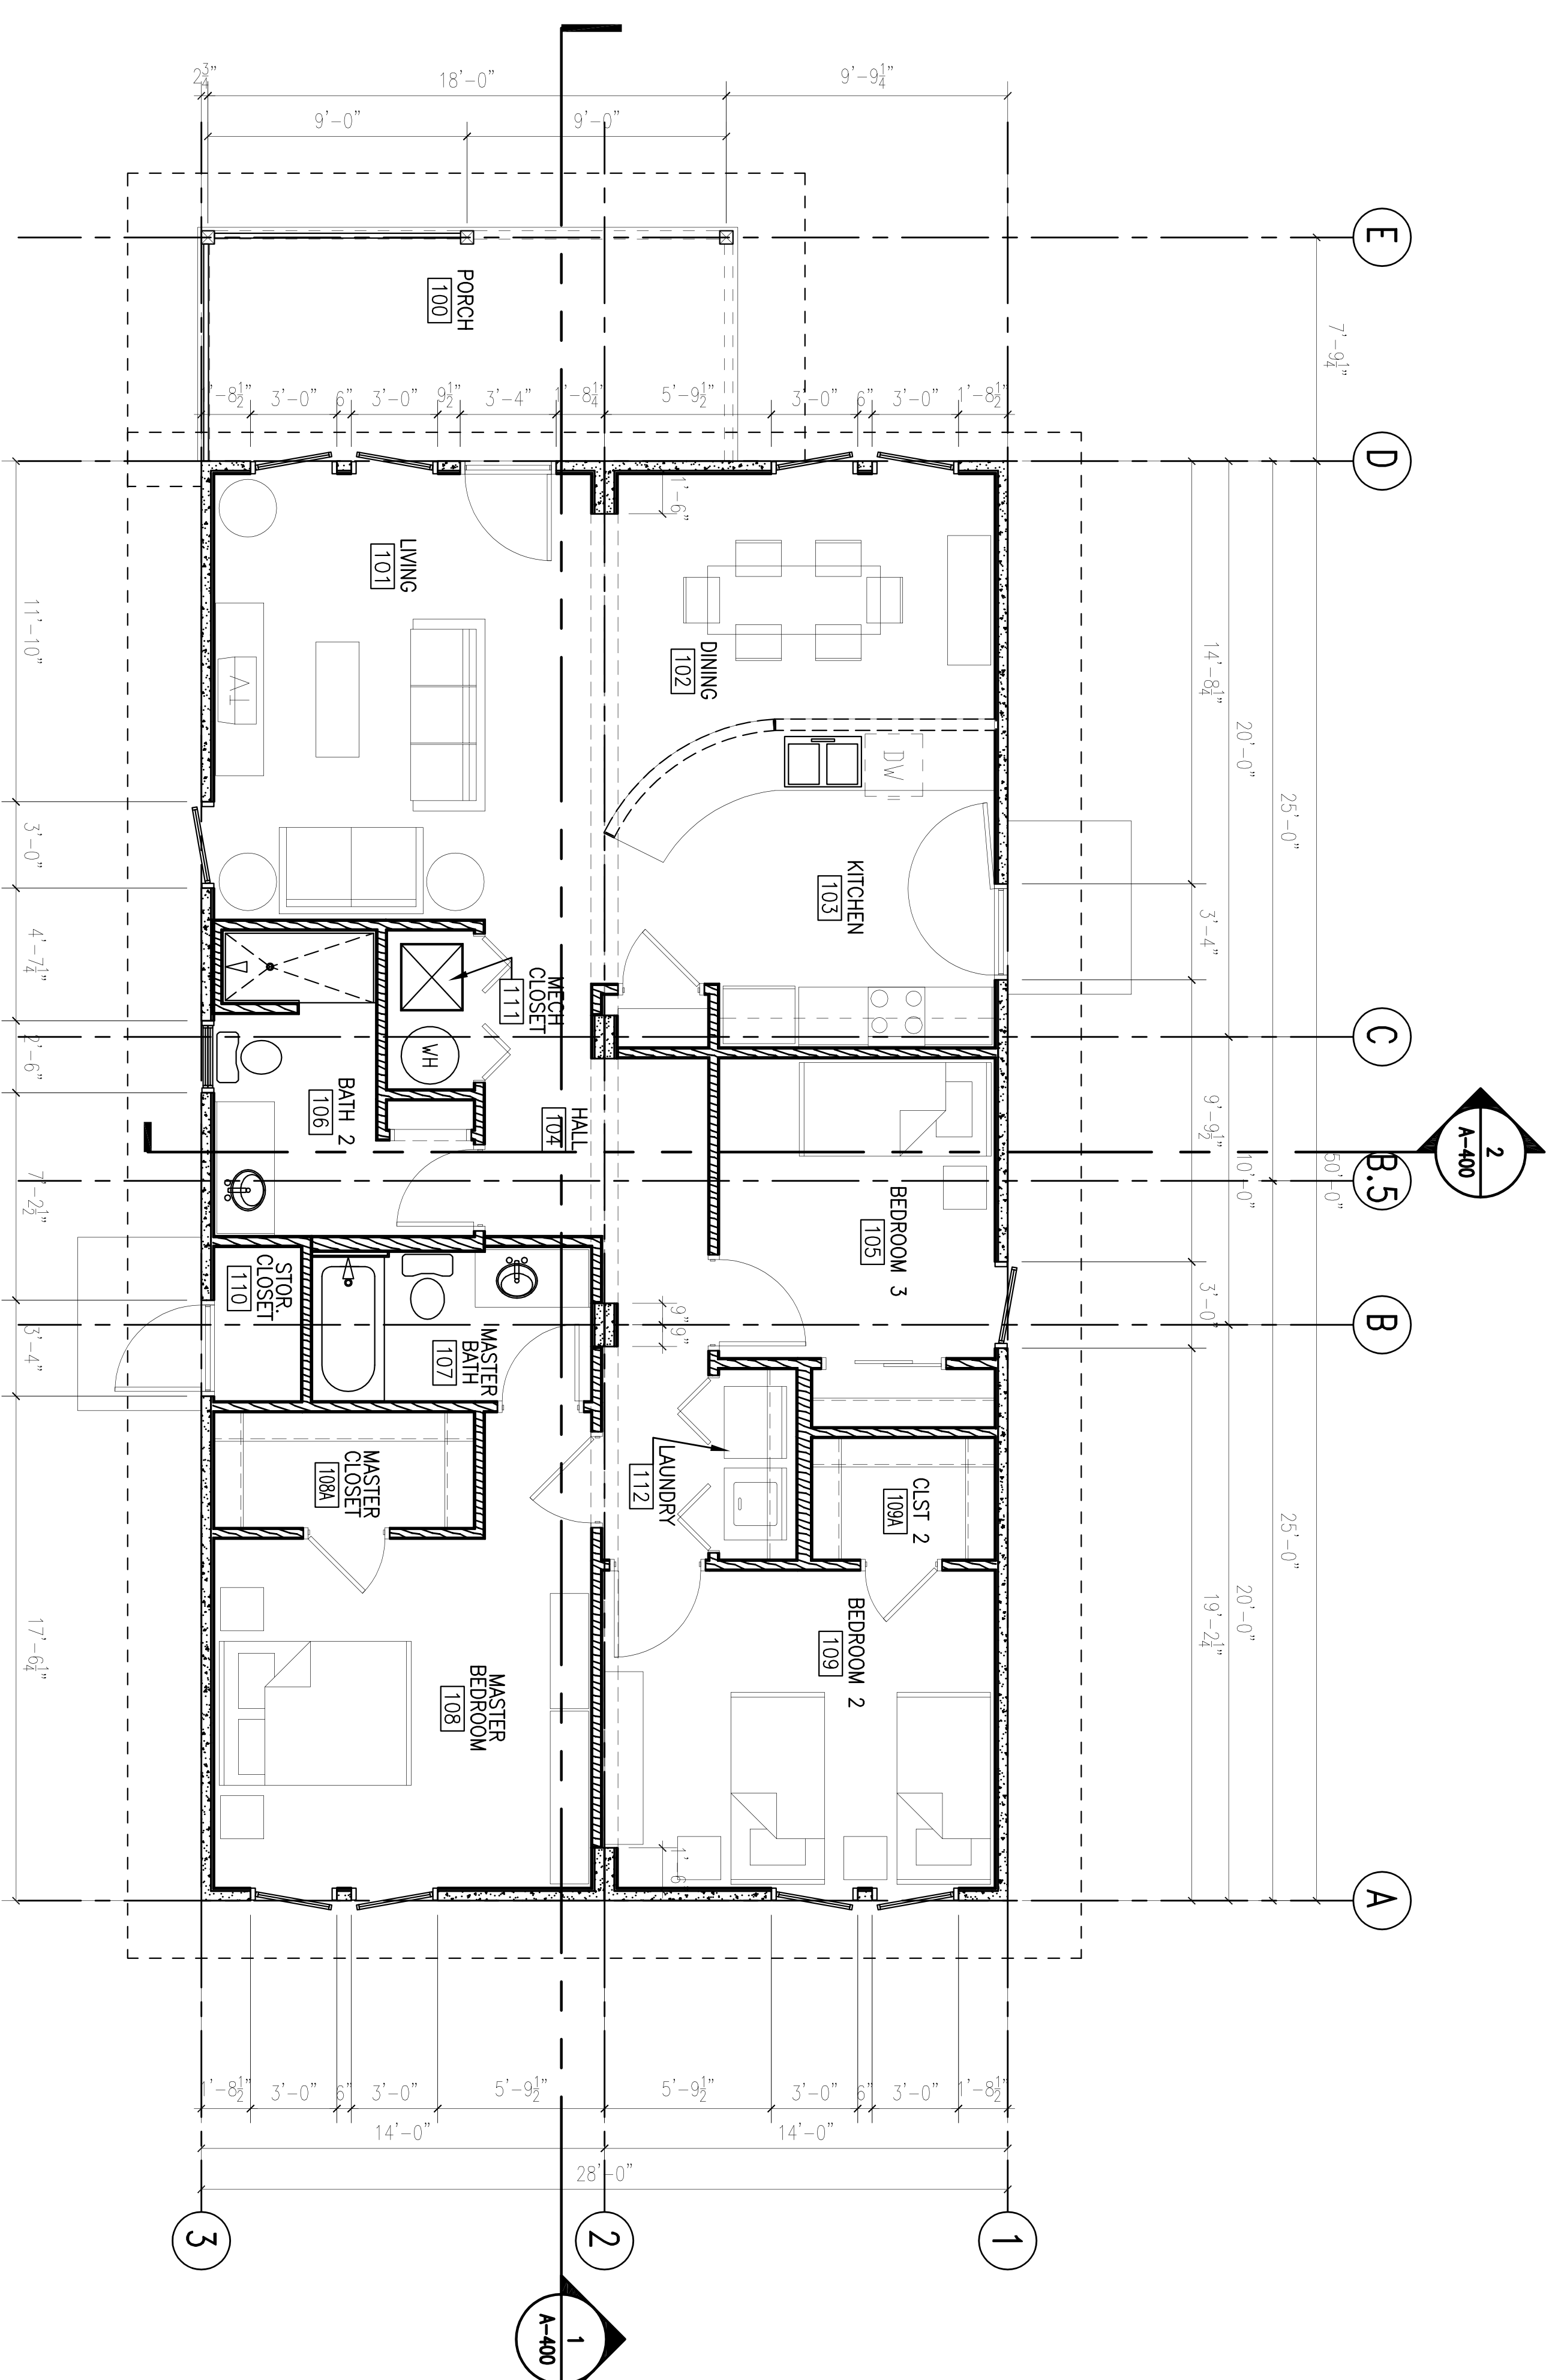

FLOOR PLAN WALL LEGEND:

	NEW CONCRETE CONSTRUCTION
	NEW WOOD FRAME CONSTRUCTION



1
A-200
SCALE: 1/4"=1'-0"

PROPOSED GROUND FLOOR PLAN FOR 14' x 25' MODULE