

**MONTENARO  
JACKSONVILLE  
HOUSE**  
NEW CONSTRUCTION

CLIENT

Montenaro USA, LLC  
2016 Selva Moderna Court  
Atlantic Beach, FL 32233

ARCHITECT

VA Concepts, LLC  
506 Third Street South  
Jacksonville Beach, FL 32250  
FL NO. A43000154


STRUCTURAL

Driscoll Engineering, Inc.  
4509 NW 23rd Avenue  
Gainesville, FL 32606  
FL NO. 43922  
Certificate of Authorization No. 6890

MECHANICAL & PLUMBING

ELECTRICAL

CONSULTANT

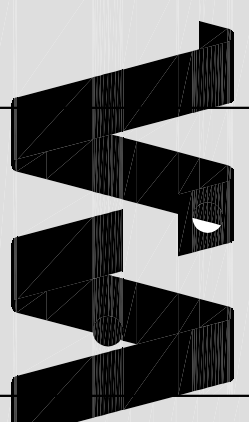



NO.	REVISION/ISSUE	DATE

**LIGHTING /  
REFLECTED  
CEILING PLAN**

**PERMIT  
DOCUMENTS**

COORDINING PROJ. NO.	PLD NO.	AS SHOWN SCALE	DATE

A-600

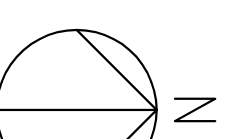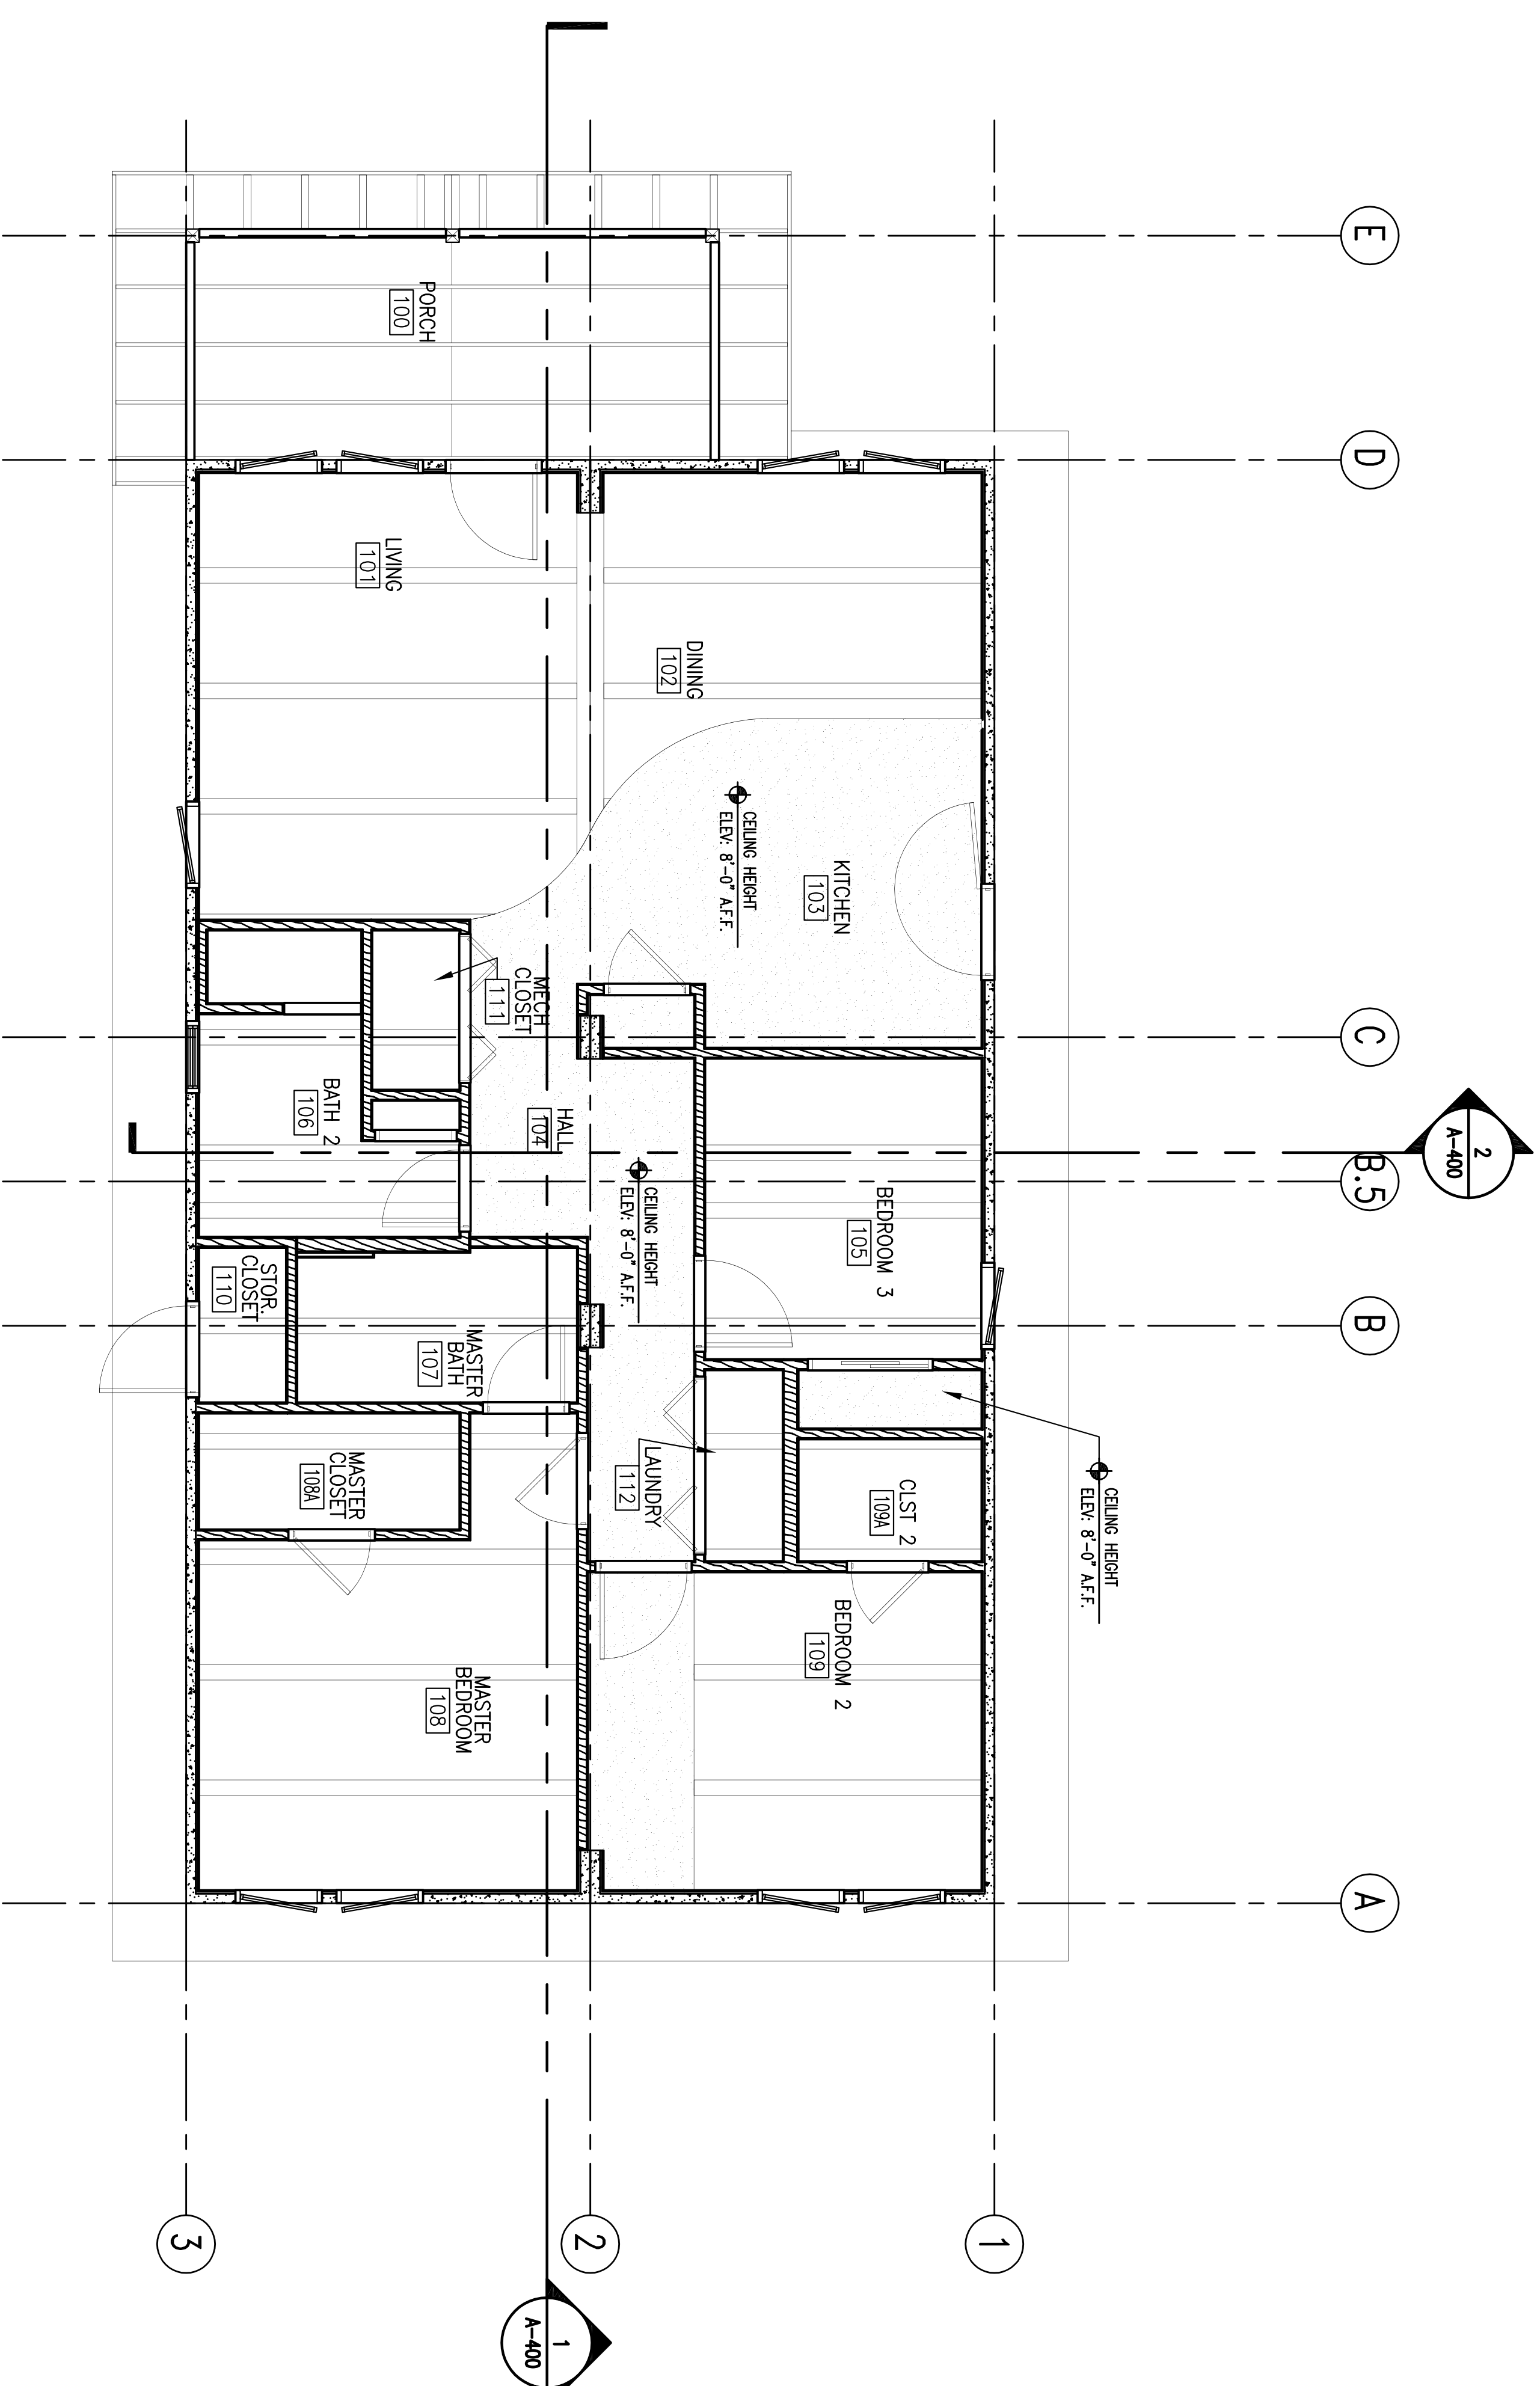

**1** LIGHTING / REFLECTED CEILING PLAN  
SCALE: 1/4"=1'-0"